


GIFA = 22.4 m²

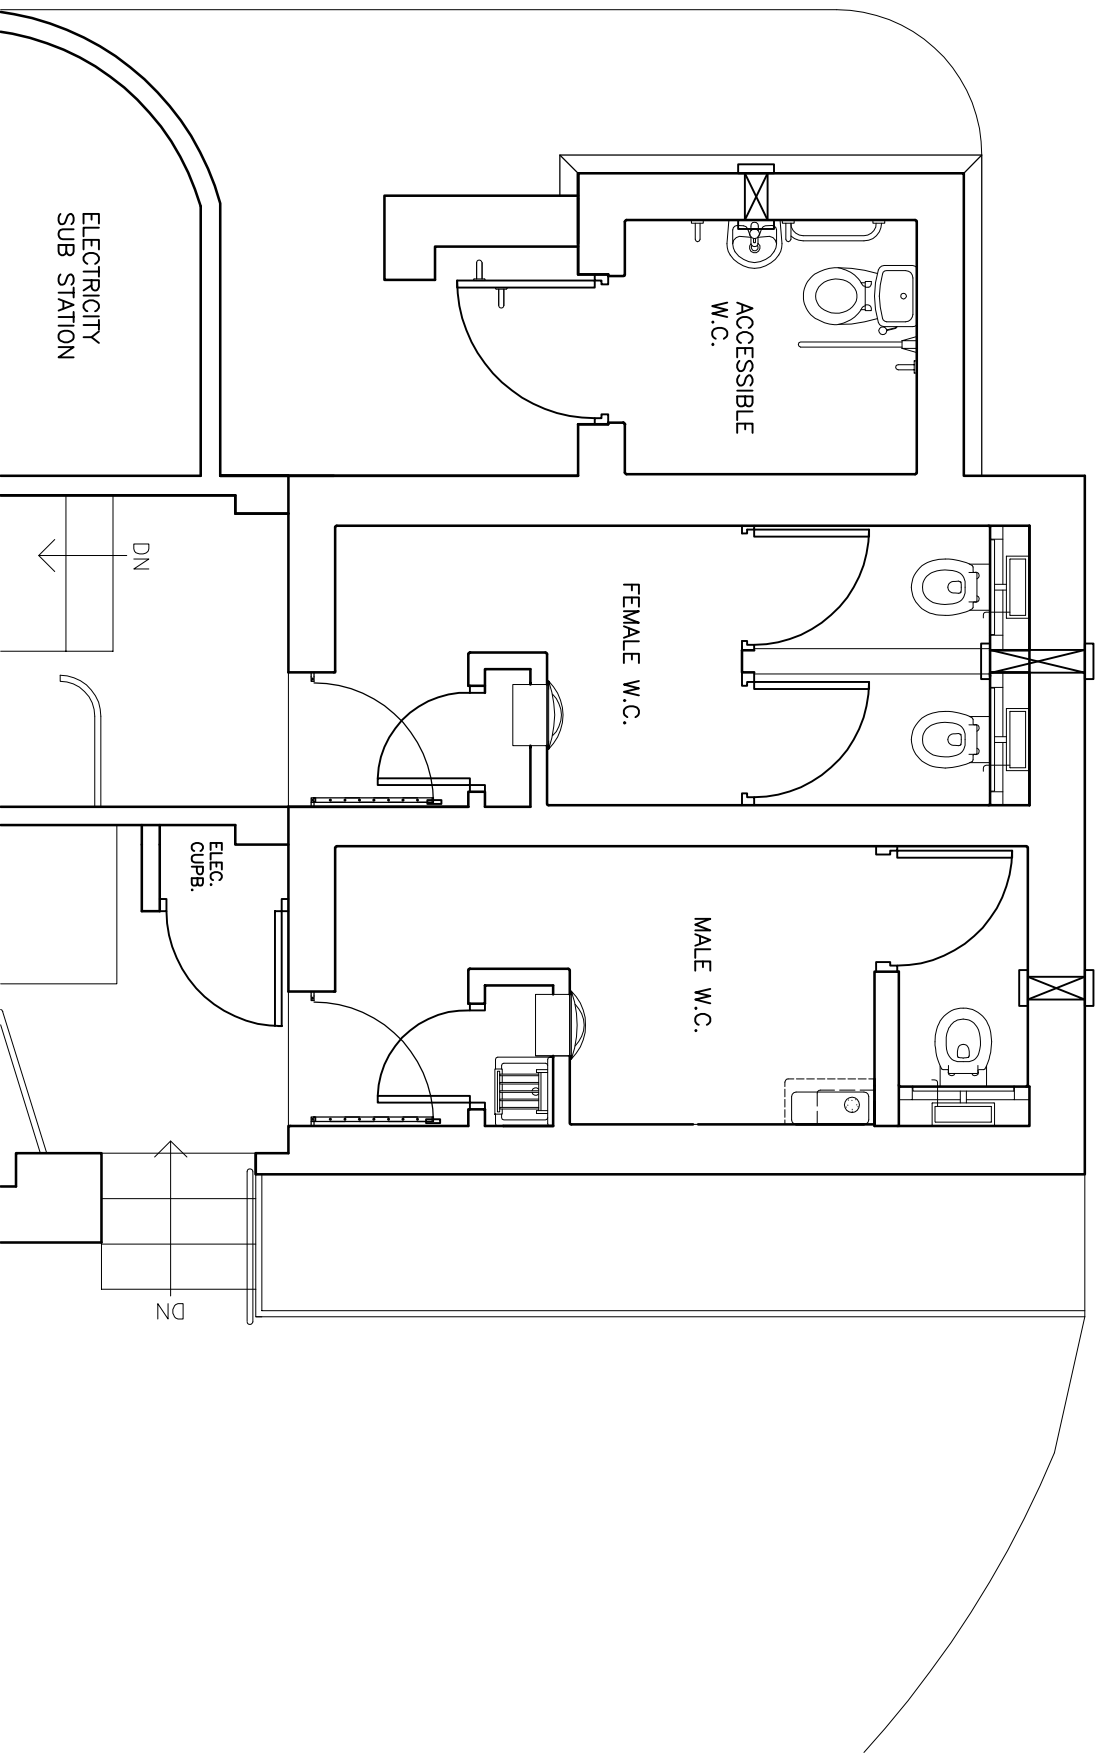

ELECTRICITY
SUB STATION

ACCESSIBLE
W.C.

FEMALE W.C.

MALE W.C.

DN

ELEC.
CUPB.

DN

FOR CONTRACTORS INFORMATION:

CONTRACTOR TO VERIFY ALL DIMENSIONS ON SITE BEFORE SETTING OUT. PREPARING SHOP DRAWINGS OR OTHERWISE COMMENCING WORK. NO DIMENSIONS FOR SETTING OUT ANY PART OF THE WORKS ARE TO BE SCALED FROM THIS DRAWING.

job:

DOLPHIN STREET TOILETS
COLLYTON

drawing:

FLOOR PLAN

scale:

1:50 @ A4

date:

drawn:

dwg No:

rev:

EAST DEVON

DISTRICT COUNCIL

www.eastdevon.gov.uk

PROPERTY SERVICES